
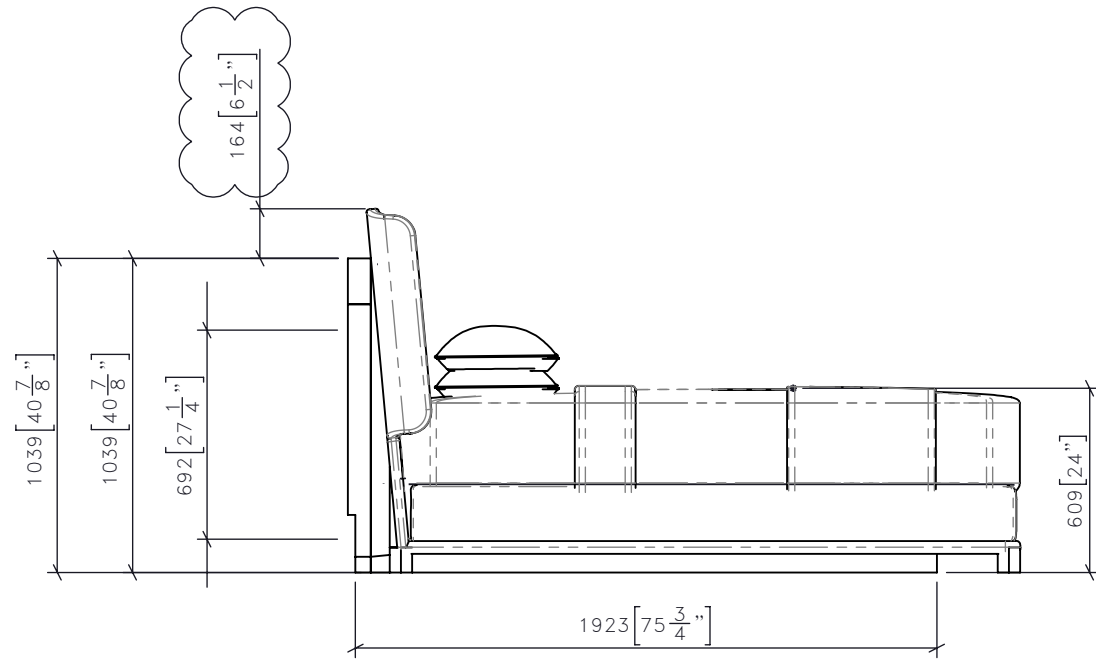


NOTE - MANUFACTURER TO SITE VERIFY FITMENT OF COMPONENTS IN ELEVATORS AND DOORWAYS


FOR DESIGN INTENT ONLY

DRAWING ARE NOT TO BE SCALED. CONTRACTOR MUST CHECK AND VERIFY ALL JOB DIMENSIONS, DRAWINGS, DETAILS AND SPECIFICATIONS; AND REPORT ANY DISCREPANCIES TO DESIGNER BEFORE PROCEEDING WITH WORK.

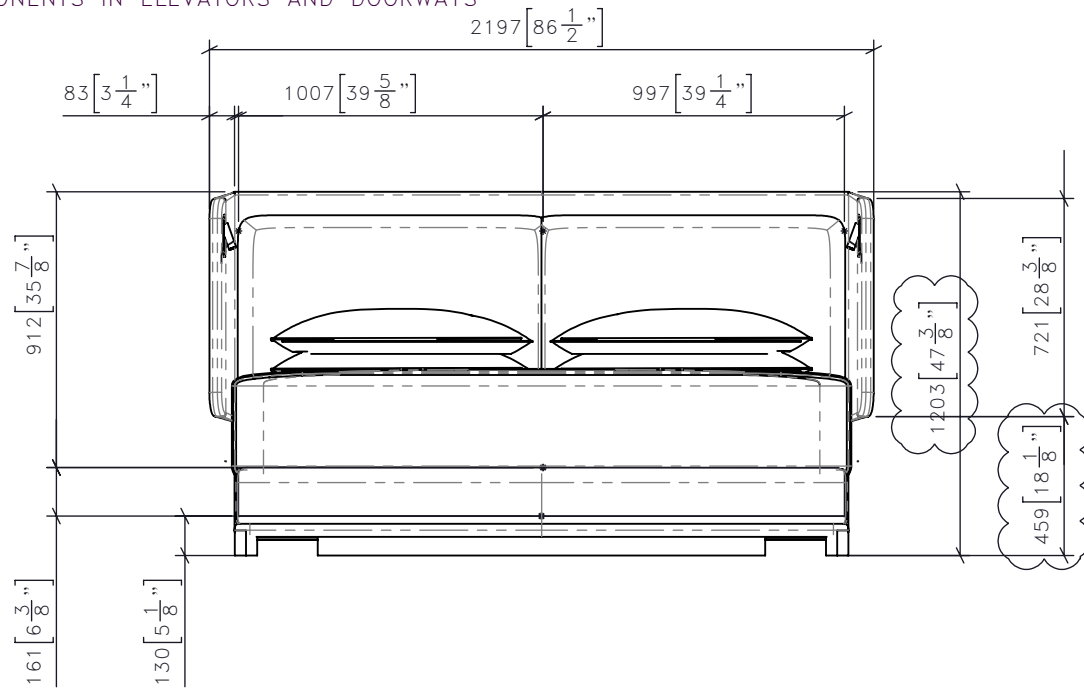


1 CG-107 TYPICAL KING BED FRONT ELEVATION 1:25

3 CG-107 TYPICAL KING BED SIDE ELEVATION 1:25

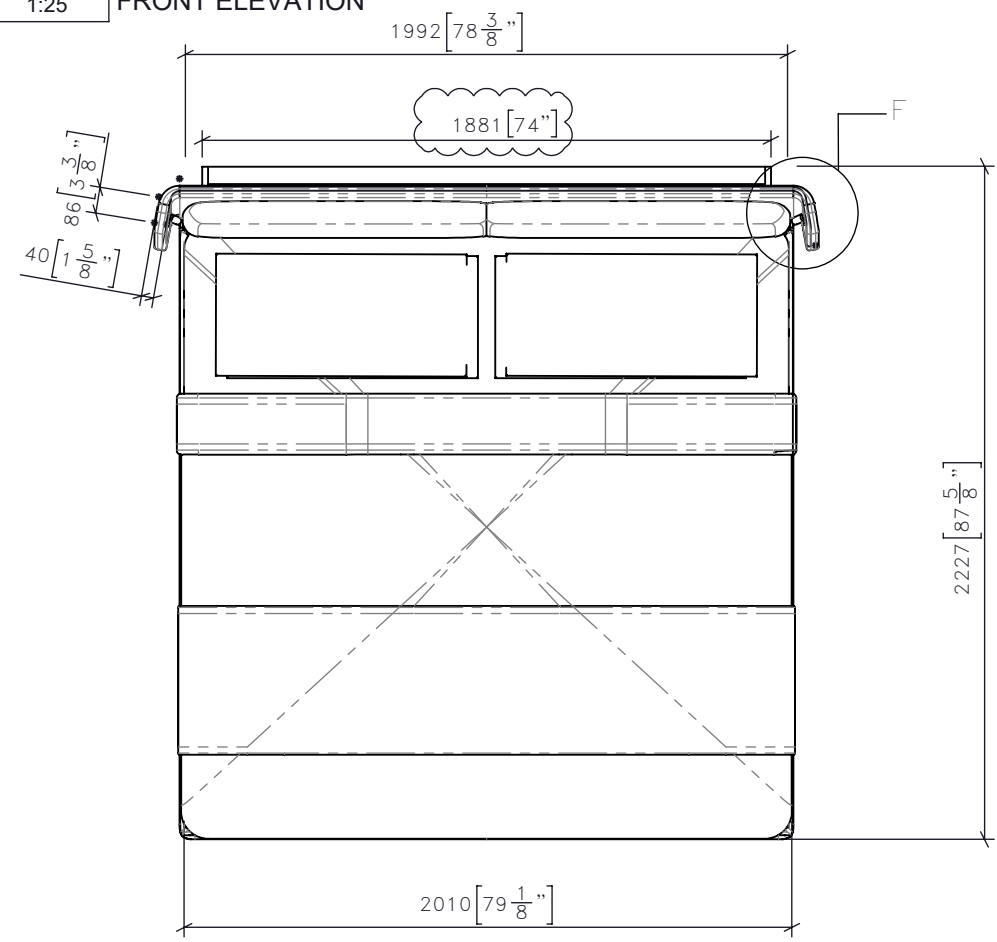

2 CG-107 TYPICAL KING BED PLAN 1:25

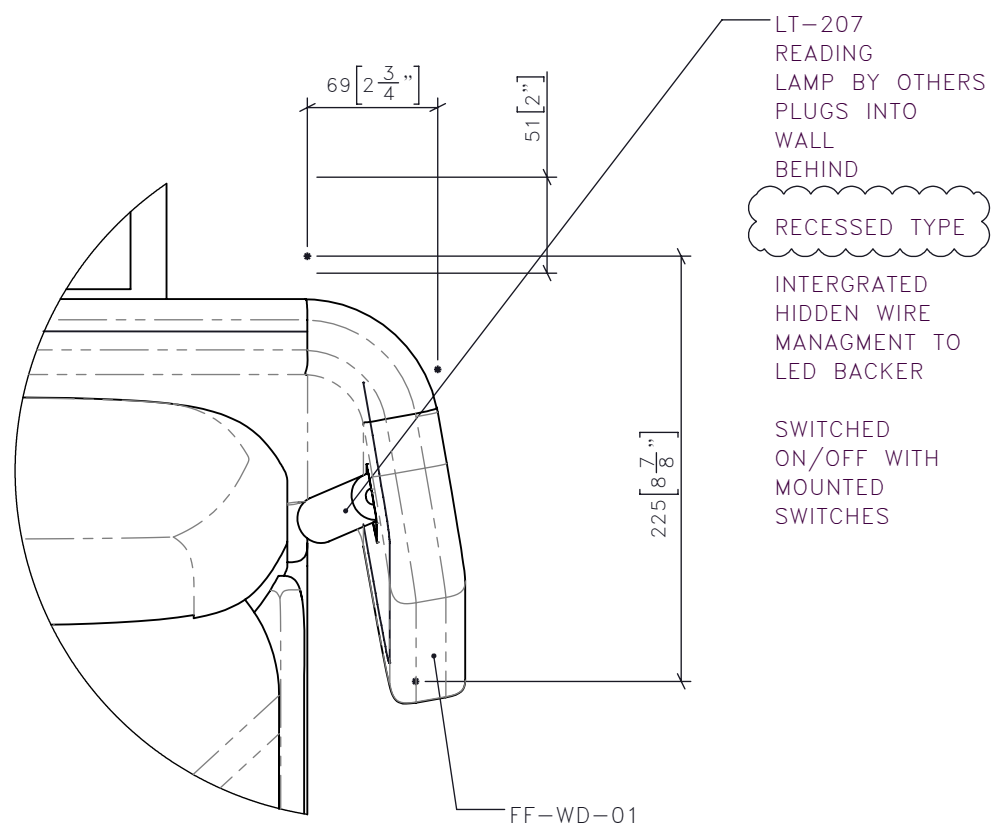

DETAIL F SCALE 1 : 4

LT-207 READING LAMP BY OTHERS PLUGS INTO WALL BEHIND

RECESSED TYPE

INTERGRATED HIDDEN WIRE MANAGMENT TO LED BACKER

SWITCHED ON/OFF WITH MOUNTED SWITCHES

HARDWOOD BASE AND LEGS CUSTOM PROFILE

-SCALE	AS NOTED	-DATE	11/17/20
-DRAWN BY	LS	-CHECKED BY	
-PROJECT NAME	DIAOYUTAI QINGDAO		
-DRAWING TITLE	CG-107 TYPICAL KING BED		
-PROJECT NUMBER	19118		
-DRAWING NUMBER	1 / 3		

STUDIO MUNGE


FOR DESIGN INTENT ONLY

DRAWING ARE NOT TO BE SCALED. CONTRACTOR MUST CHECK AND VERIFY ALL JOB DIMENSIONS, DRAWINGS, DETAILS AND SPECIFICATIONS; AND REPORT ANY DISCREPANCIES TO DESIGNER BEFORE PROCEEDING WITH WORK.

-REV/	-ISSUED FOR	-DATE

ACCENT PILLOWS AC-207

THROW BLANKET AC-201

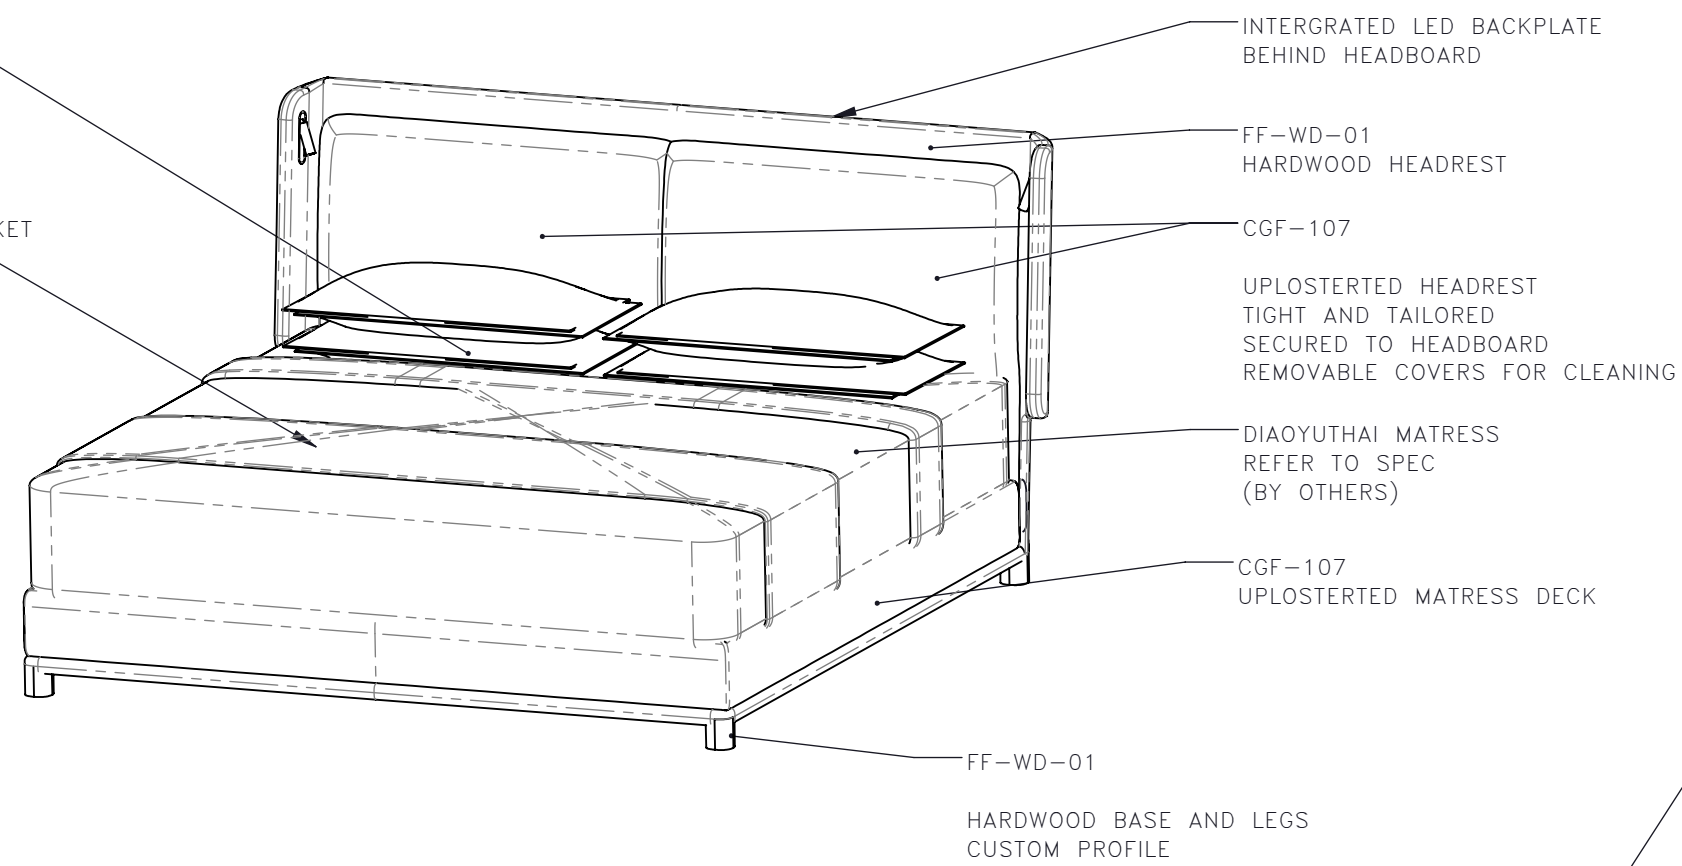


DIAOYUTHAI MATTRESS REFER TO SPEC (BY OTHERS)

7 CG-107 TYPICAL KING BED DETAILED DIMETRIC
1:20

INDICATES LED STRIP LIGHTING IN 45 DEGREE ALUMINUM CHANNEL WITH OPAL DIFFUSER 2700 K SUPPLY WITH PLUG END TO PLUG INTO WALL BEHIND

LED TO WIRE TO HEADBOARD MOUNTED SWITCH TO CONTROL ON/OFF

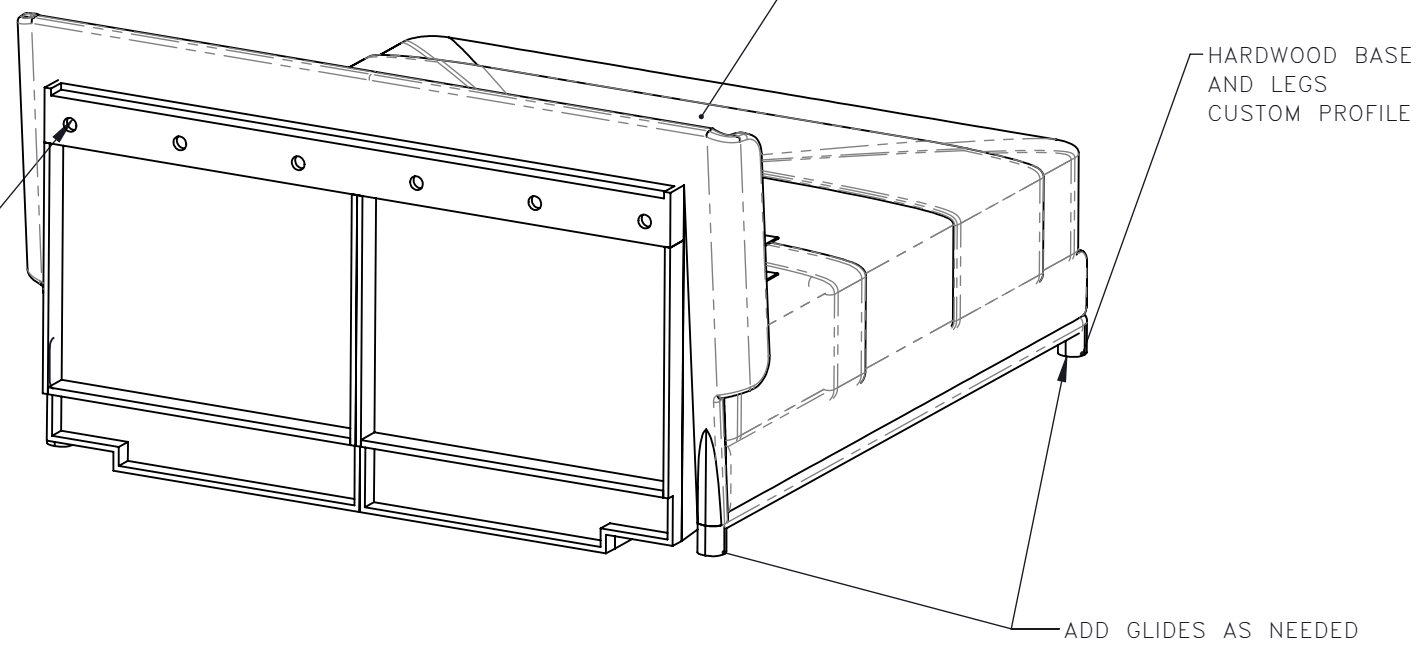

8 CG-107 TYPICAL KING BED DETAILED DIMETRIC
1:20

STUDIO MUNGE
25 WINGOLD AVENUE
TORONTO, ONTARIO
M6B 1P8 CANADA
416.588.1668
STUDIOMUNGE.COM

-SCALE AS NOTED	-DATE 11/17/20
-DRAWN BY LS	-CHECKED BY
-PROJECT NAME DIAOYUTAI QINGDAO	
-DRAWING TITLE CG-107 TYPICAL KING BED	
-PROJECT NUMBER 19118	
-DRAWING NUMBER 2 / 3	

STUDIO MUNGE
Y
M
D
C
B
A
Y

FOR DESIGN INTENT ONLY

DRAWING ARE NOT TO BE SCALED. CONTRACTOR MUST CHECK AND VERIFY ALL JOB DIMENSIONS, DRAWINGS, DETAILS AND SPECIFICATIONS; AND REPORT ANY DISCREPANCIES TO DESIGNER BEFORE PROCEEDING WITH WORK.

-REV/	-ISSUED FOR	-DATE



STUDIO MUNGE
25 WINGOLD AVENUE
TORONTO, ONTARIO
M6B 1P8 CANADA
416.588.1668
STUDIOMUNGE.COM

9 | CG-107 | TYPICAL KING BED
1:20 | RENDERED VIEW

-SCALE AS NOTED	-DATE 11/17/20
-DRAWN BY LS	-CHECKED BY
-PROJECT NAME DIAOYUTAI QINGDAO	
-DRAWING TITLE CG-107 TYPICAL KING BED	
-PROJECT NUMBER 19118	
-DRAWING NUMBER 3 / 3	