
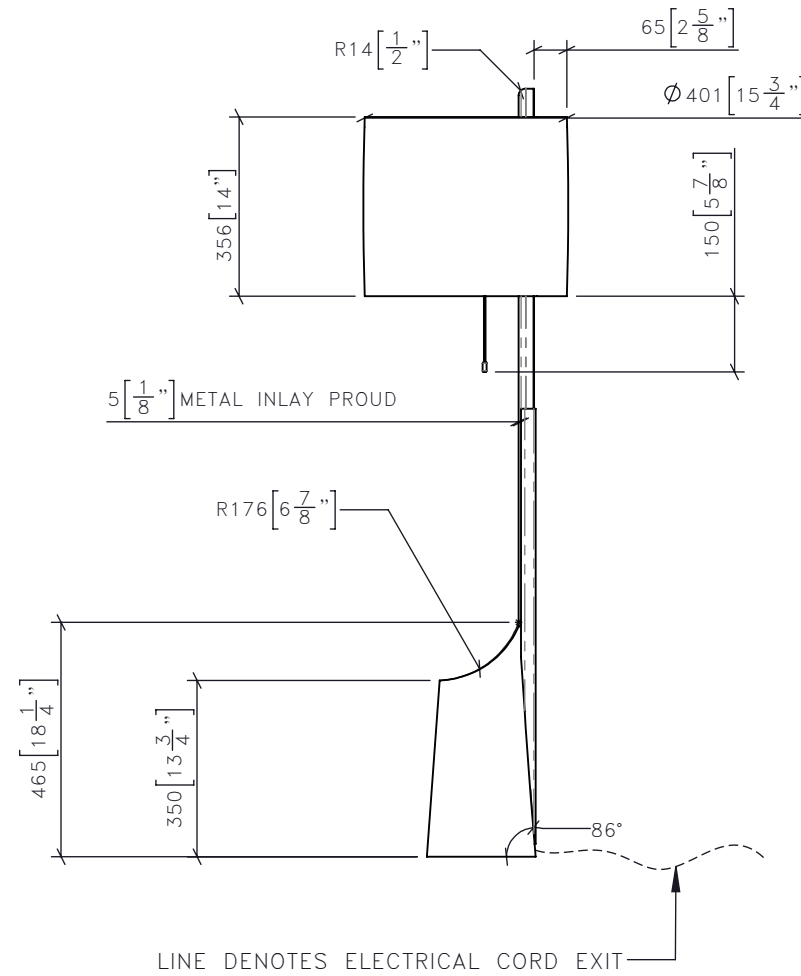


STUDIO MUNGE

NOTE - MANUFACTURER TO ENSURE UNIT IS STABLE/SECURE FOR HOSPITALITY USE


FOR DESIGN INTENT ONLY

DRAWING ARE NOT TO BE SCALED. CONTRACTOR MUST CHECK AND VERIFY ALL JOB DIMENSIONS, DRAWINGS, DETAILS AND SPECIFICATIONS; AND REPORT ANY DISCREPANCIES TO DESIGNER BEFORE PROCEEDING WITH WORK.

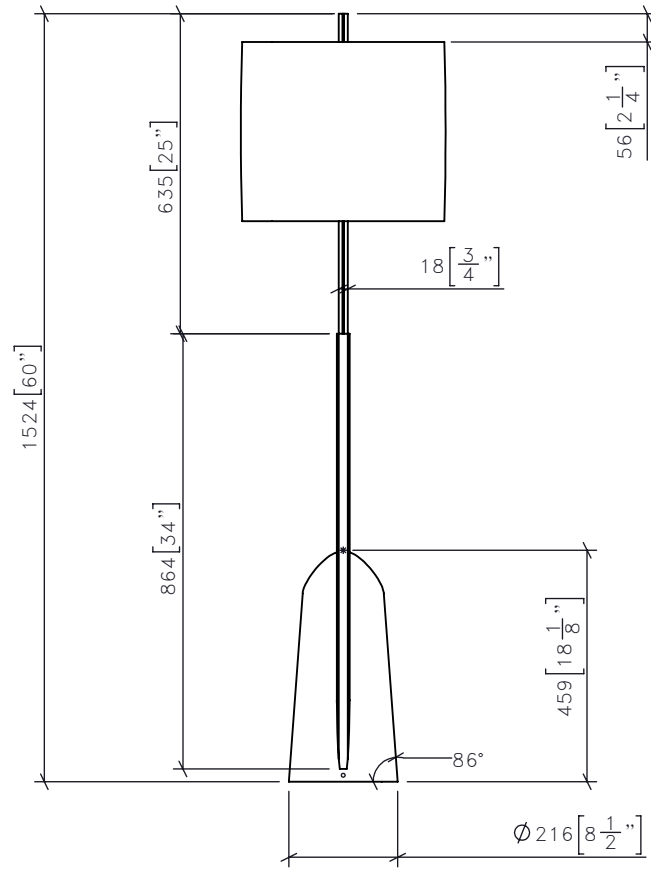


1 LA-101 FLOOR LAMP (TYPE A)
1:15 FRONT ELEVATION

3 LA-101 FLOOR LAMP (TYPE A)
1:15 SIDE ELEVATION

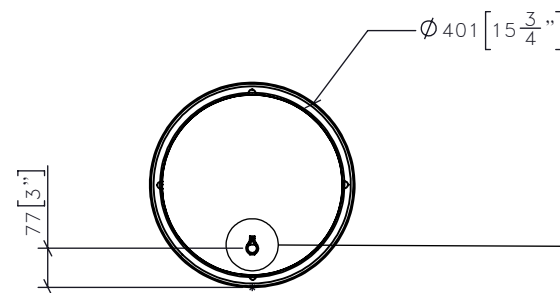

2 LA-101 FLOOR LAMP (TYPE A)
1:15 PLAN

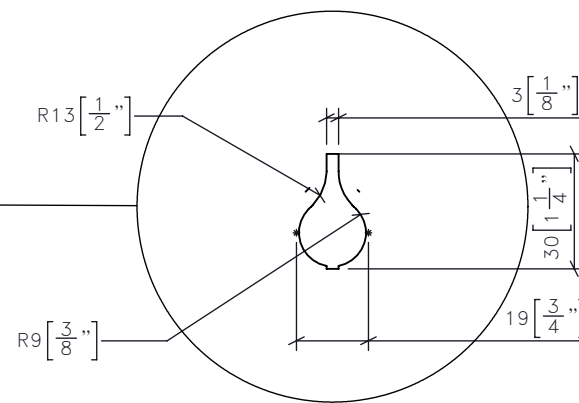

DETAIL F
CUSTOM METAL PROFILE
SCALE 1 : 2

-REV	-ISSUED FOR	-DATE

STUDIO MUNGE
25 WINGOLD AVENUE
TORONTO, ONTARIO
M6B 1P8 CANADA
416.588.1668
STUDIOMUNGE.COM

-SCALE AS NOTED	-DATE 6/11/19
-DRAWN BY LS	-CHECKED BY
-PROJECT NAME MGM QINGDAO	
-DRAWING TITLE LA-101 FLOOR LAMP (TYPE A)	
-PROJECT NUMBER 17126	
-DRAWING NUMBER 1 / 3	

STUDIO MUNGE

NOTE - MANUFACTURER TO ENSURE UNIT IS STABLE/SECURE FOR HOSPITALITY USE

FOR DESIGN INTENT ONLY

DRAWING ARE NOT TO BE SCALED. CONTRACTOR MUST CHECK AND VERIFY ALL JOB DIMENSIONS, DRAWINGS, DETAILS AND SPECIFICATIONS; AND REPORT ANY DISCREPANCIES TO DESIGNER BEFORE PROCEEDING WITH WORK.

-REV/	-ISSUED FOR	-DATE

STUDIO MUNGE
 25 WINGOLD AVENUE
 TORONTO, ONTARIO
 M6B 1P8 CANADA
 416.588.1668
 STUDIOMUNGE.COM

-SCALE AS NOTED	-DATE 6/11/19
-DRAWN BY LS	-CHECKED BY
-PROJECT NAME MGM QINGDAO	
-DRAWING TITLE LA-101 FLOOR LAMP (TYPE A)	
-PROJECT NUMBER 17126	
-DRAWING NUMBER 2 / 3	

METAL ARMATURE
CUSTOM PROFILE
FF-ML-101

FABRIC LAMP SHADE
LAF-101A

DIFFUSER SHADE

DECORATIVE WOOD SURROUD
FF-WD-101

METAL ARMATURE
CUSTOM PROFILE
FF-ML-101

METAL INLAY DETAIL
PROUD OF WOOD
6MM
FF-ML-101

CARVED STONE BASE
FF-ST-102

MANUFACTURER TO
ENSURE STABILITY
OF LIGHING FIXTURE

NOTE: ALL VISIBLE WELDS CLEANED

MANUFACTURER TO
SUGGEST LAMP LAYOUT

LED SPEC AS PER
LIGHTING CONSULSTANT
SPEC

DIFFUSER SHADE

METAL SPIDER
FF-ML-101

METAL HARP
FF-ML-101

DIFFUSER SHADE

DRAW STRING
SWITCH TO
CONTROL LIGHT
3-WAY
BRIGHTNESS
LED DIMMABLE

REFER TO LIGHTING
CONSULTANT
SPECS

4	LA-101	FLOOR LAMP (TYPE A) FRONT ISOMETRIC
	1:10	

5	LA-101	FLOOR LAMP (TYPE A) FRONT ISOMETRIC (NO SHADE)
	1:10	

STUDIO MUNGE
Y
E
M
D
C
B
A
Y

FOR DESIGN INTENT ONLY

DRAWING ARE NOT TO BE SCALED. CONTRACTOR MUST CHECK AND VERIFY ALL JOB DIMENSIONS, DRAWINGS, DETAILS AND SPECIFICATIONS; AND REPORT ANY DISCREPANCIES TO DESIGNER BEFORE PROCEEDING WITH WORK.

-REV/	-ISSUED FOR	-DATE



**STUDIO
MUNGE**
25 WINGOLD AVENUE
TORONTO, ONTARIO
M6B 1P8 CANADA
416.588.1668
STUDIOMUNGE.COM

-SCALE
AS NOTED

-DATE
6/11/19

-DRAWN BY
LS

-CHECKED BY

-PROJECT NAME

MGM QINGDAO

-DRAWING TITLE

LA-101
FLOOR LAMP (TYPE A)

-PROJECT NUMBER
17126

-DRAWING NUMBER
3 / 3