

STUDIO MUNGE

**HARDWIRED LIGHTS INSTRUCTONS:**

- DRAWINGS PROVIDED ARE FOR DESIGN INTENT ONLY-ID
- TO BE CONTRACT QUALITY
- DRIVER TO BE COORDINATED WITH ELECTRICAL ENGINEER
- HARDWARE TO BE CONTRACT GRADE AND REVIEWED BY SM FOR APPROVAL
- SUBMITTAL OF SHOP DRAWINGS, FINISH SAMPLES, AND/OR PROTOTYPE TO STUDIO MUNGE FOR REVIEW AND WRITTEN APPROVAL IS REQUIRED FOR ALL FIXTURES SUPPLIED BY INDICATED VENDOR OR OTHER
- PURCHASING AGENT TO SUBMIT ALL NEW SUBSTITUTIONS TO STUDIO MUNGE FOR WRITTEN APPROVAL PRIOR TO MANUFACTURING AND PURCHASING
- CORD NOTE-SPECIFIC TO PIECE

SPECIFICATIONS	DESCRIPTION	QTY
WEIGHT	~25 lbs	
SWITCH TYPE	N/A (HARD WIRED)	
CORD LENGHT/COLOR	N/A (HARD WIRED)	
LAMP TYPE/WATTAGE	200mm ROUND LED RING, 2700K	
UL LISTING	N/A	
DIMMER	DIMMABLE	
<b>REQUIRED ITEM(S) FOR DESIGNER APPROVAL PRIOR TO FABRICATION</b>		
<input type="checkbox"/> SEAMING DIAGRAM <input type="checkbox"/> SHOP DRAWINGS <input type="checkbox"/> PROTOTYPE <input type="checkbox"/> FINISH SAMPLE		


DRAWING ARE NOT TO BE SCALED. CONTRACTOR MUST CHECK AND VERIFY ALL JOB DIMENSIONS, DRAWINGS, DETAILS AND SPECIFICATIONS; AND REPORT ANY DISCREPANCIES TO DESIGNER BEFORE PROCEEDING WITH WORK.

REV	ISSUED FOR	DATE

**MATERIAL INSTRUCTONS:**

-MATERIALS TO BE OUTDOOR GRADE WHEN REQUIRED AND SPECIFIED IN DRAWINGS AND ORDER

MATERIAL CODE	DESCRIPTION	COLOR/FINISH
FF-GL-8001	GLASS	REFER TO SPEC. PACKAGE
FF-ML-8001	METAL	REFER TO SPEC. PACKAGE

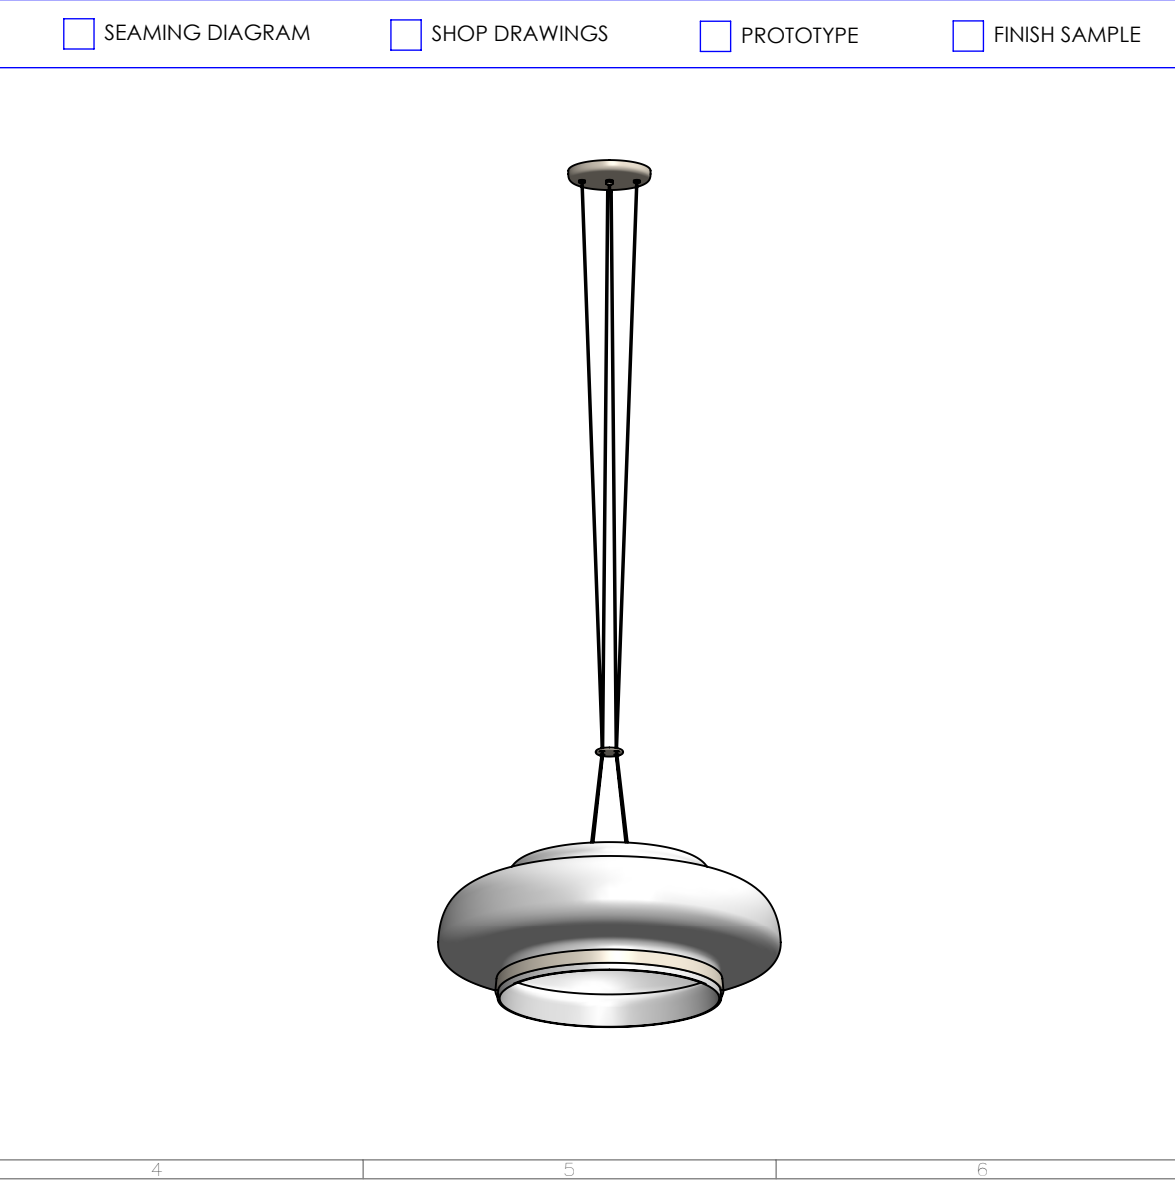

**STUDIO MUNGE**  
 25 WINGOLD AVENUE  
 TORONTO, ONTARIO  
 M6B 1P8 CANADA  
 416.588.1668  
 STUDIOMUNGE.COM

**-SCALE**  
AS NOTED

**-DATE**  
5/20/21

**-DRAWN BY**  
CS

**-CHECKED BY**

**-PROJECT NAME**  
MGM QINGDAO

**-DRAWING TITLE**  
LT-8002  
PENDANT LIGHT

**-PROJECT NUMBER**  
17126

**-DRAWING NUMBER**  
1 / 4


STUDIO MUNGE  
Y  
E  
D  
C  
B  
A  
Y  
X

DRAWING ARE NOT TO BE SCALED. CONTRACTOR MUST CHECK AND VERIFY ALL JOB DIMENSIONS, DRAWINGS, DETAILS AND SPECIFICATIONS; AND REPORT ANY DISCREPANCIES TO DESIGNER BEFORE PROCEEDING WITH WORK.

REV	ISSUED FOR	DATE

**STUDIO  
MUNGE**  
25 WINGOLD AVENUE  
TORONTO, ONTARIO  
M6B 1P8 CANADA  
416.588.1668  
STUDIOMUNGE.COM

<b>-SCALE</b> AS NOTED	<b>-DATE</b> 5/20/21
<b>-DRAWN BY</b> CS	<b>-CHECKED BY</b> 
<b>-PROJECT NAME</b>  MGM QINGDAO	
<b>-DRAWING TITLE</b>  LT-8002 PENDANT LIGHT	
<b>-PROJECT NUMBER</b> 17126	
<b>-DRAWING NUMBER</b> 2 / 4	

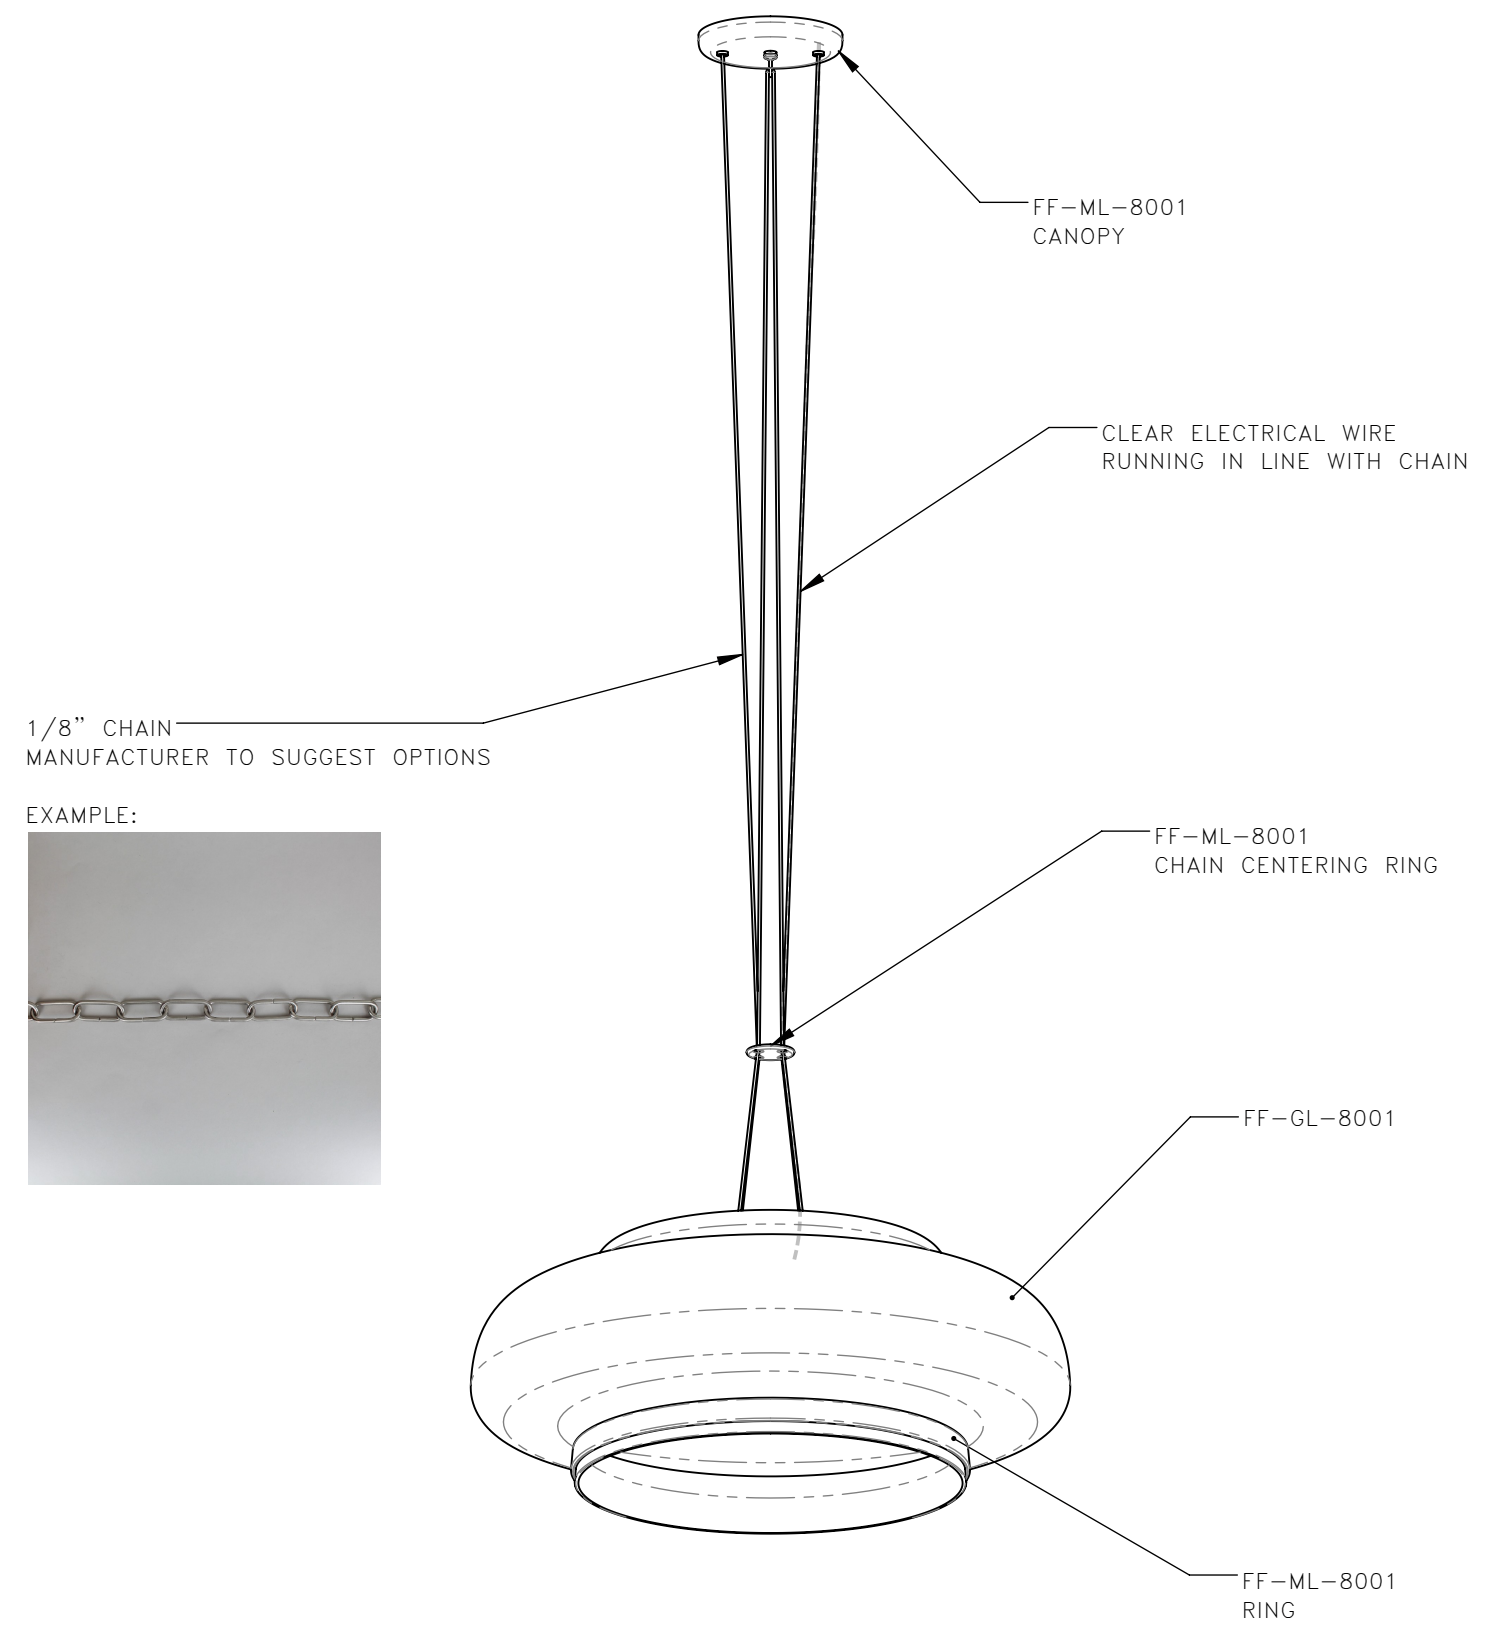


**1** LT-8002 PENDANT LIGHT  
1:8 ISO FRONT

DRAWING ARE NOT TO BE SCALED. CONTRACTOR MUST CHECK AND VERIFY ALL JOB DIMENSIONS, DRAWINGS, DETAILS AND SPECIFICATIONS, AND REPORT ANY DISCREPANCIES TO DESIGNER BEFORE PROCEEDING WITH WORK.

REV	ISSUED FOR	DATE

**STUDIO MUNGE**  
 25 WINGOLD AVENUE  
 TORONTO, ONTARIO  
 M6B 1P8 CANADA  
 416.588.1668  
 STUDIOMUNGE.COM

SCALE AS NOTED	DATE 5/20/21
DRAWN BY CS	CHECKED BY
PROJECT NAME  MGM QINGDAO	
DRAWING TITLE  LT-8002 PENDANT LIGHT	
PROJECT NUMBER 17126	
DRAWING NUMBER 3 / 4	

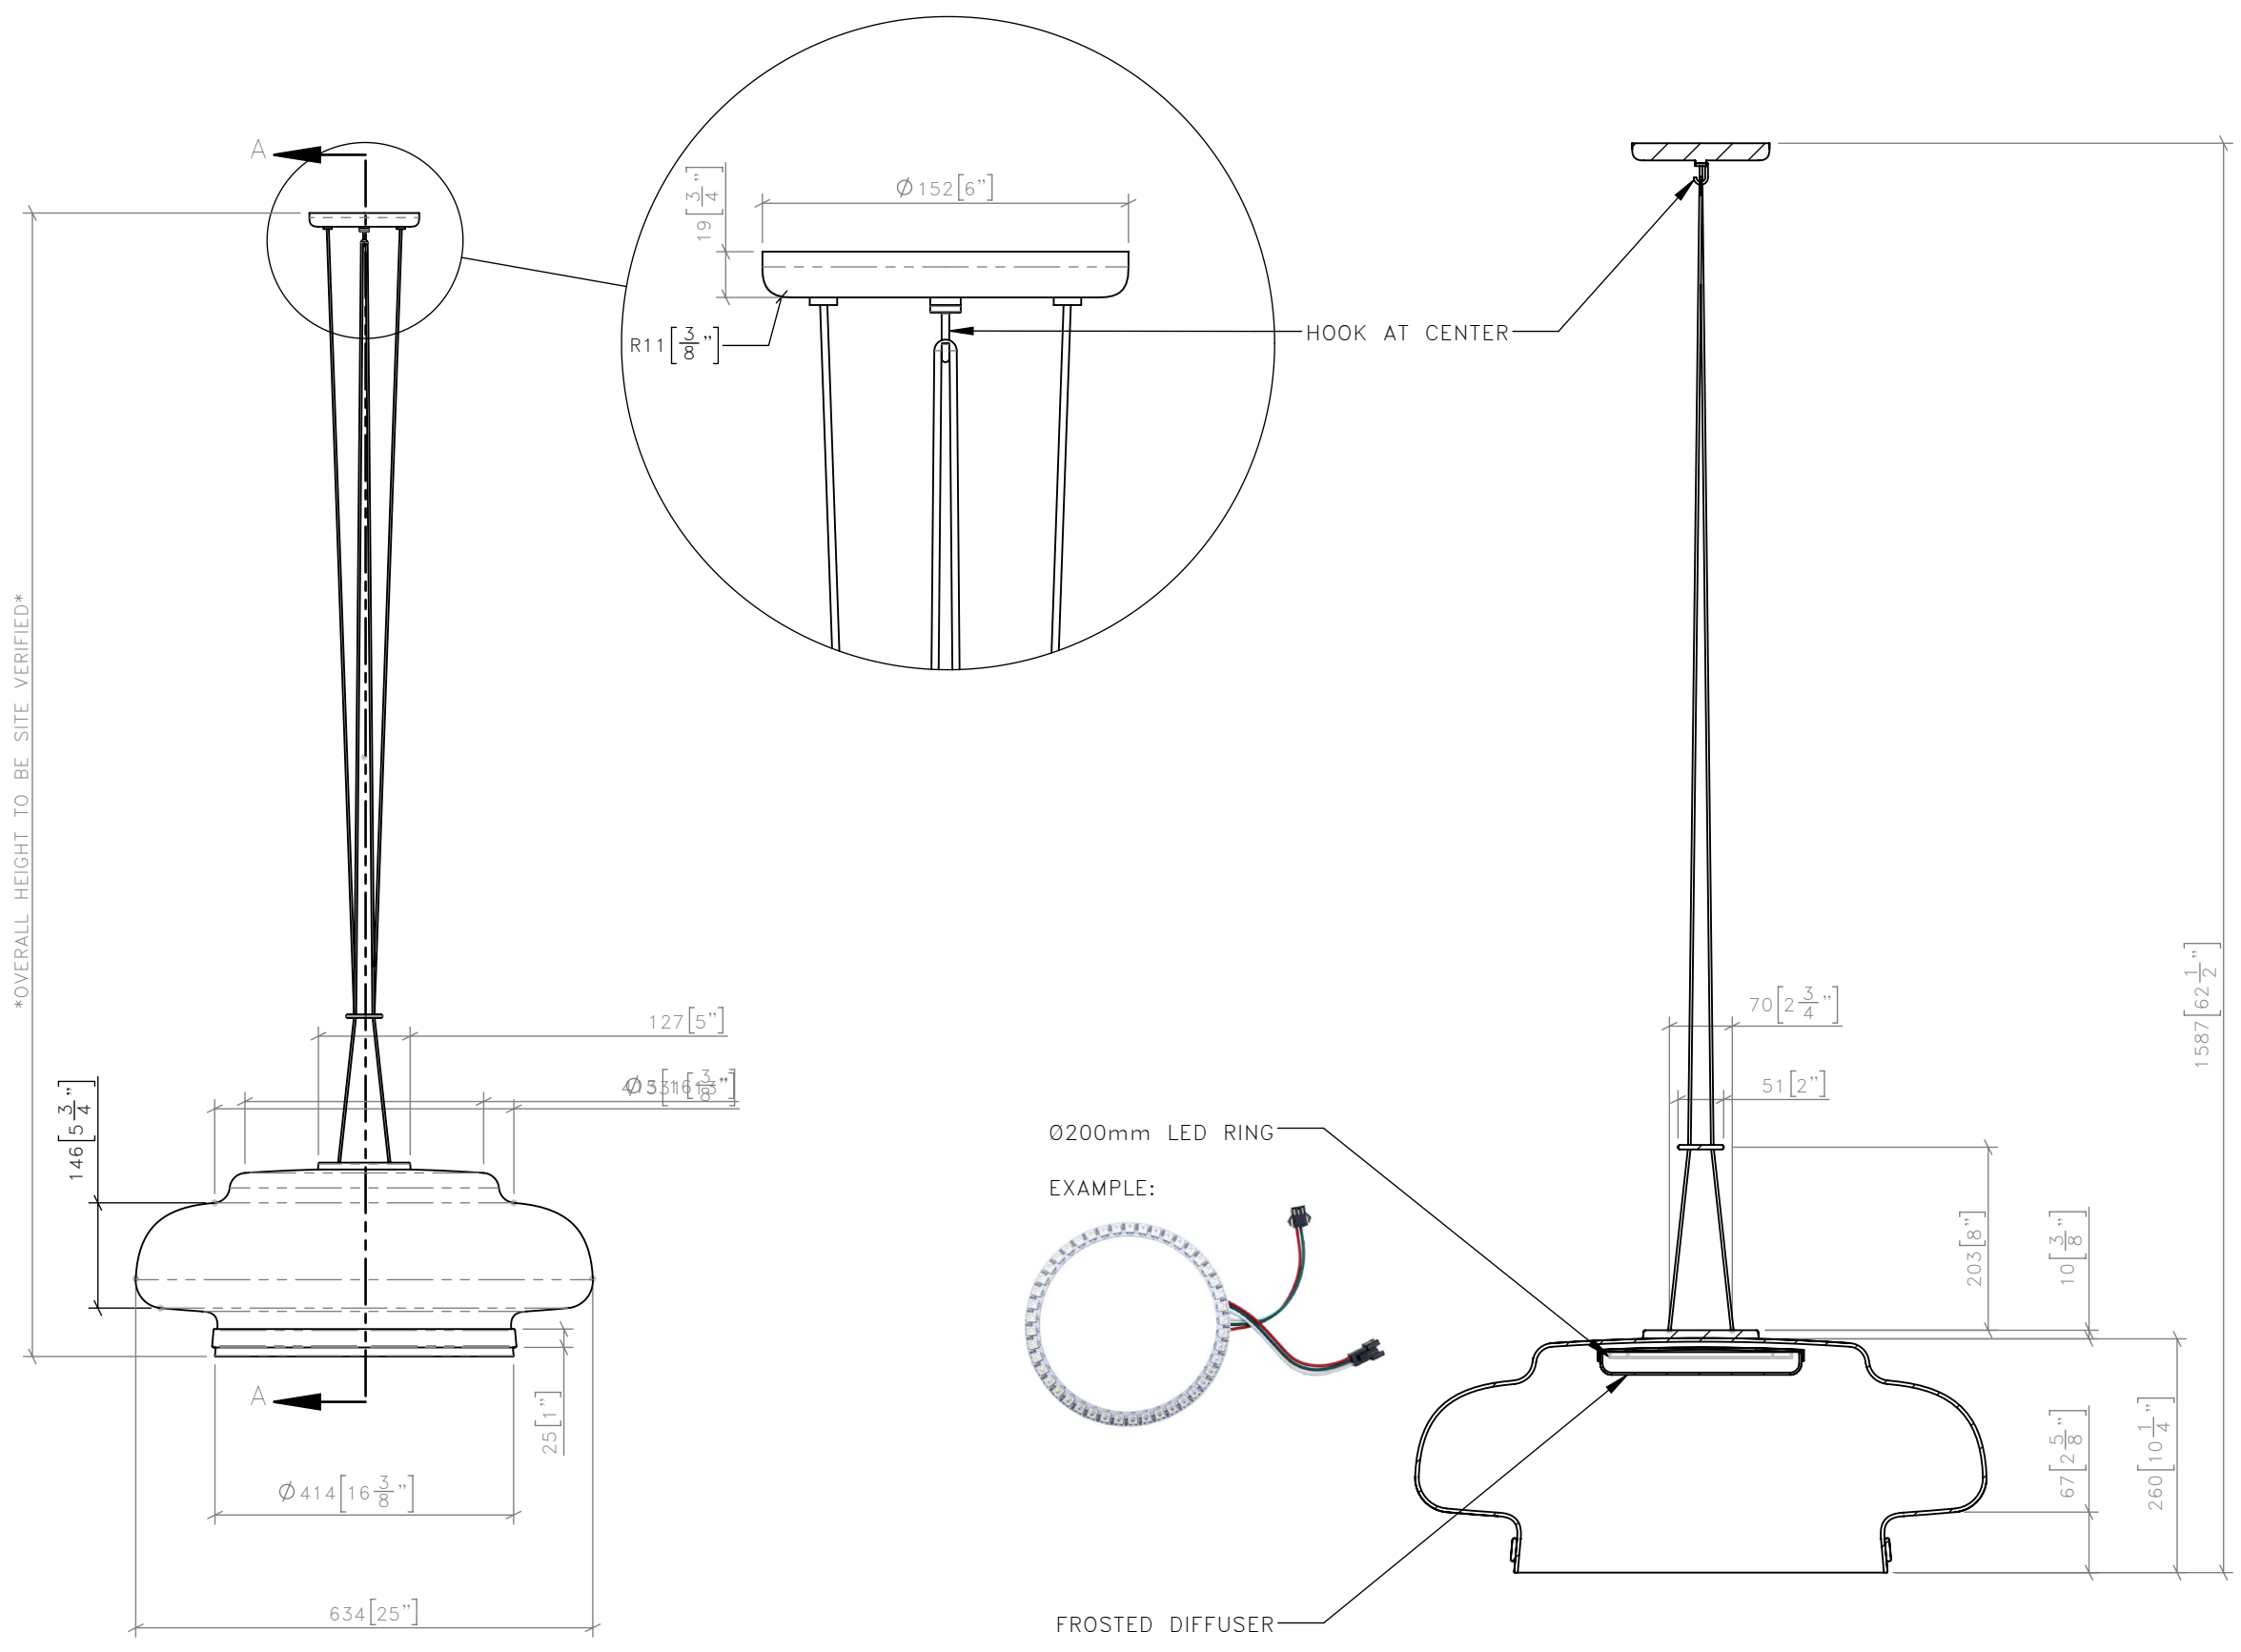

**2** LT-8002 PENDANT LIGHT FRONT ELEVATION  
1:10

**3** LT-8002 PENDANT LIGHT SECTION A-A  
1:10

STUDIO MUNGE  
Y  
E  
D  
C  
B  
A  
Y

1


2

3

4

5

6

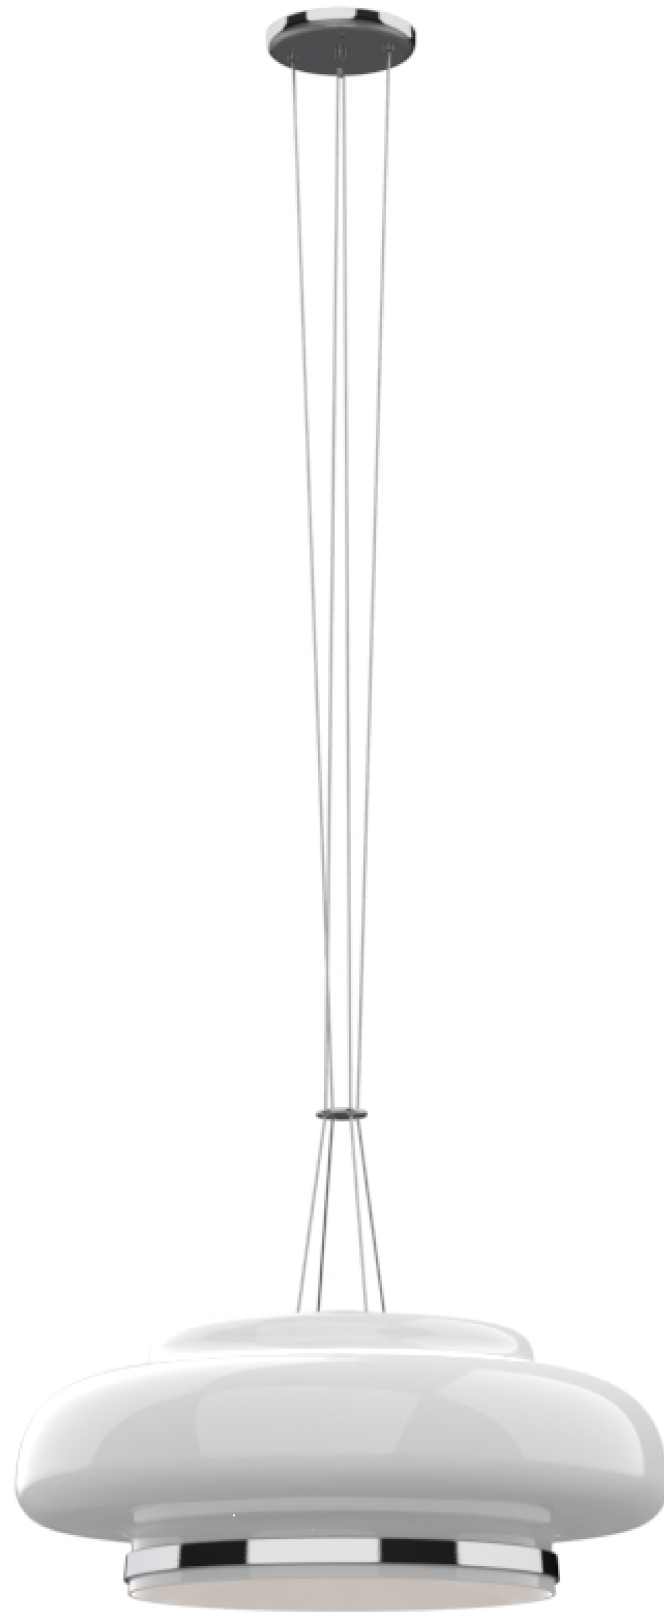

4	LT-8002	PENDANT LIGHT
	1:10	RENDERED VIEW

DRAWING ARE NOT TO BE SCALED. CONTRACTOR MUST CHECK AND VERIFY ALL JOB DIMENSIONS, DRAWINGS, DETAILS AND SPECIFICATIONS; AND REPORT ANY DISCREPANCIES TO DESIGNER BEFORE PROCEEDING WITH WORK.

REV	ISSUED FOR	DATE

**STUDIO  
MUNGE**  
25 WINGOLD AVENUE  
TORONTO, ONTARIO  
M6B 1P8 CANADA  
416.588.1668  
STUDIOMUNGE.COM

<b>SCALE</b> AS NOTED	<b>DATE</b> 5/20/21
<b>DRAWN BY</b> CS	<b>CHECKED BY</b> 
<b>PROJECT NAME</b>  MGM QINGDAO	
<b>DRAWING TITLE</b>  LT-8002 PENDANT LIGHT	
<b>PROJECT NUMBER</b> 17126	
<b>DRAWING NUMBER</b> 4 / 4	

1

2

3

4

5

6